



REPUBLIC OF THE PHILIPPINES  
**DEPARTMENT OF BUDGET AND MANAGEMENT**  
GENERAL SOLANO STREET, SAN MIGUEL, MANILA

**SUPPLEMENTAL/ BID BULLETIN (SBB) NO. 3**

This SBB No. 3 dated December 21, 2017 for the Project, “Renovation of the DBM Arcache Building,” is issued to clarify, modify or amend items in the Bidding Documents. Accordingly, this shall form an integral part of said Documents.

<b>PARTICULARS</b>	<b>CLARIFICATION/AMENDMENTS</b>
<b>Section VII. Drawings</b>	<b>Section VII. Drawings</b>
<b>Revised Drawings (Supplemental No. 3)</b>	<b>Revised Drawings (Supplemental No. 3)</b>
	<b>Bid Bulletin No. 3 Plans</b>
	➤ Please refer to the attached additional drawings.

**Other matters:**




- The “No Contract Rule” shall be strictly observed. Bidders are not allowed to call or talk to any member of the Bids and Awards Committee, Technical Working Group or Secretariat effective December 28, 2017 right after the opening of bids.
  
- For guidance and information of all concerned.

  
**RYANS S. LITA**  
*Vice Chairperson, DBM-BAC*

***Revised Drawings***  
***(Supplemental No. 3)***

**1.0 ADDITIONAL DRAWINGS**

SHEET NO.	REVISIONS	BID BUL NO.
<b>E-12</b>	Additional details for Generator Room	<b>BB3-01</b>
<b>E-13</b>	Additional details for Generator Room	<b>BB3-02</b>

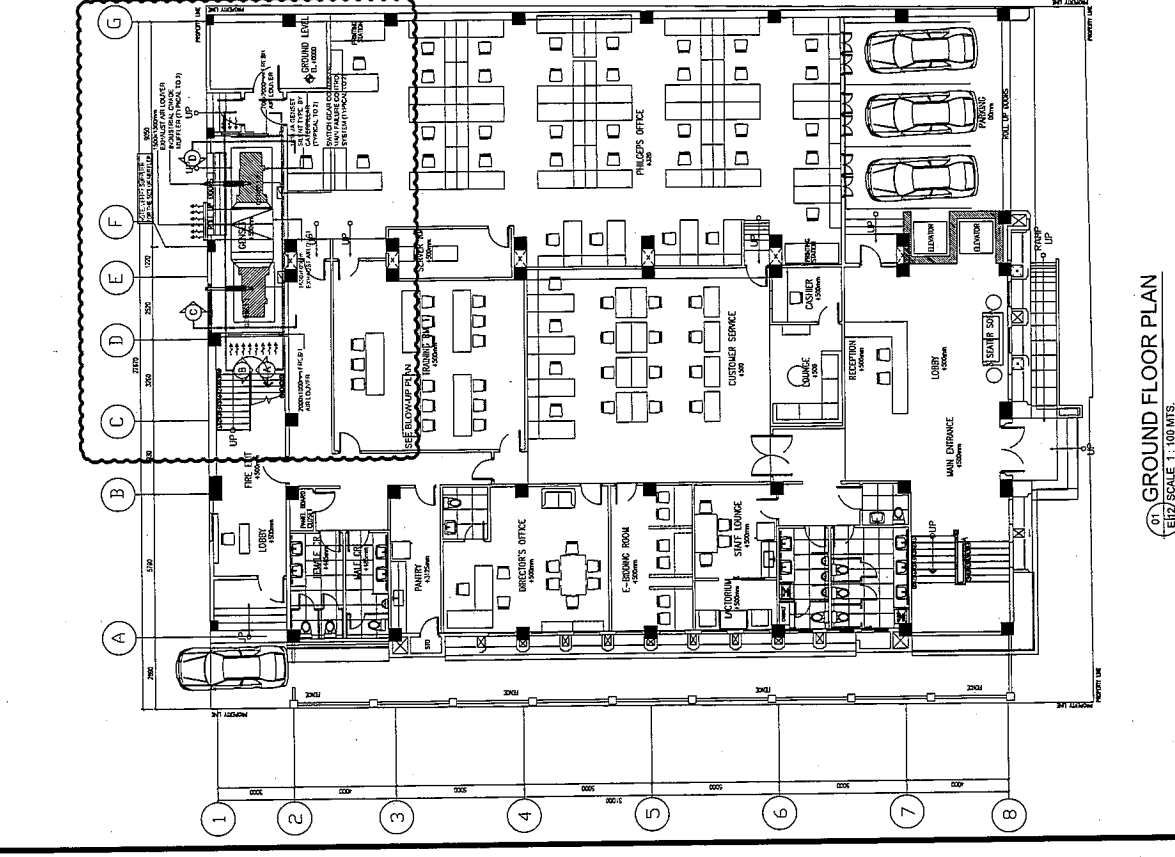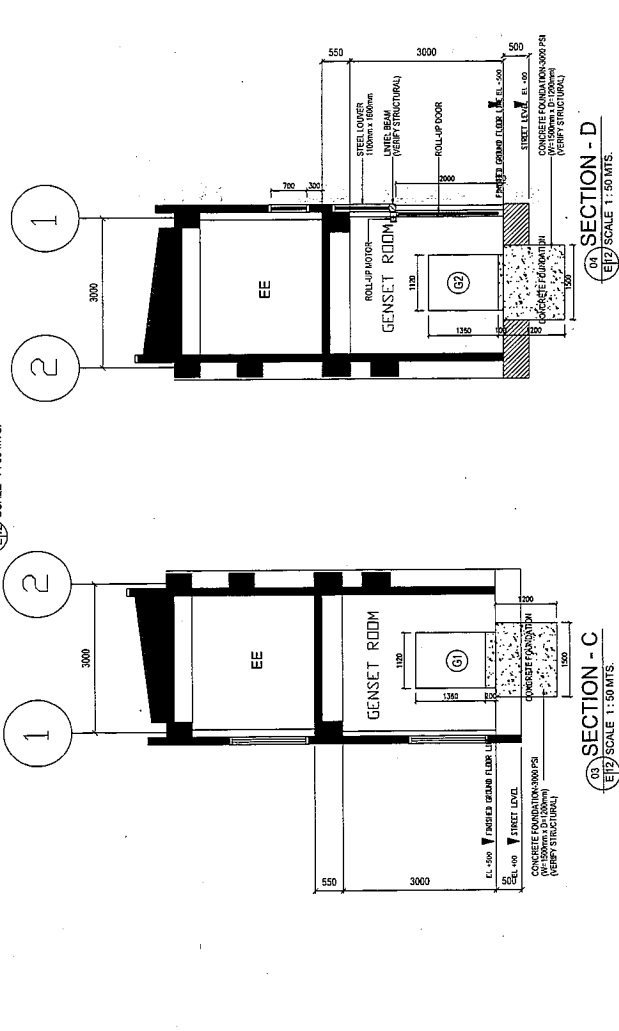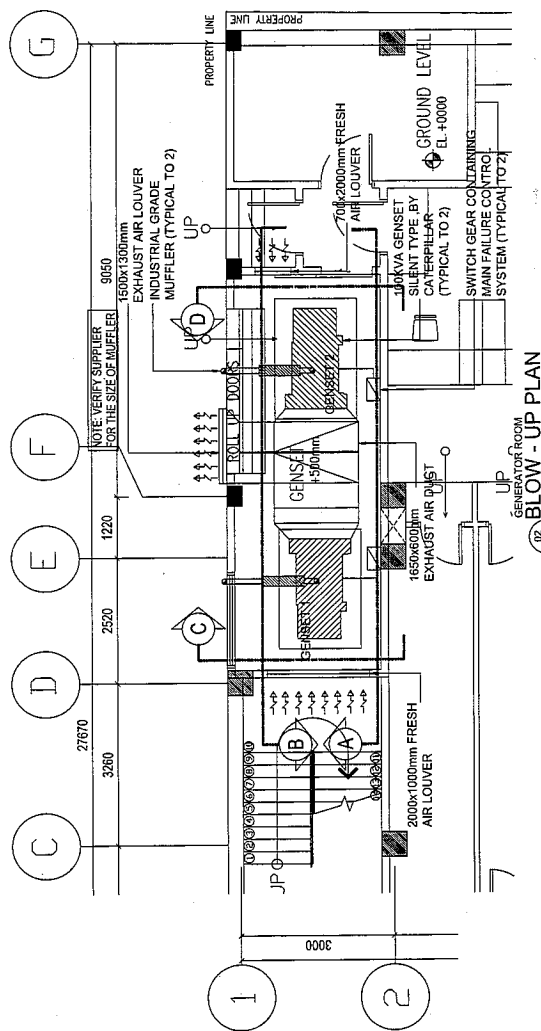


01 GROUND FLOOR PLAN  
E1/2 SCALE 1:100 MTS.

02 SECTION - C  
E1/2 SCALE 1:50 MTS.


03 SECTION - D  
E1/2 SCALE 1:50 MTS.

UNIVERSITY OF THE PHILIPPINES SYSTEM OFFICE OF THE VICE PRESIDENT FOR DEVELOPMENT ODPI OFFICE OF DESIGN AND PLANNING INITIATIVES	ARCHITECTS OF RECORD DOLORES CECILIA F. TAYSON JESUS MOURMOUNG C. BULANG ROSCOLD J. REYNOLDA POSTAL/TEL/FAC/EXT/ZIP 0917/0917/0917/0917/0917 1101 1101 1101 1101 1101	CONSULTANT/ENGINEER ENRICO B. LABAKUNDA DIRECTOR EMMA A. ZAVORA REGISTERED ARCHITECT	PROJECT TITLE <b>THREE - STOREY BUILDING RENOVATION</b> Department of Budget and Management Atacocha Building MANILA, C.T.O. AREA	UNIVERSITY REPRESENTATIVE ENRICO B. LABAKUNDA DIRECTOR EMMA A. ZAVORA REGISTERED ARCHITECT	OWNER BENJAMINE ODONDO DEPARTMENT	DRAWN BY DIO SHEI CONRIBS	SHEET NO. BB3 01
					CHECKED BY RJP	DATE 17.08.2017	DESIGNED BY DIO



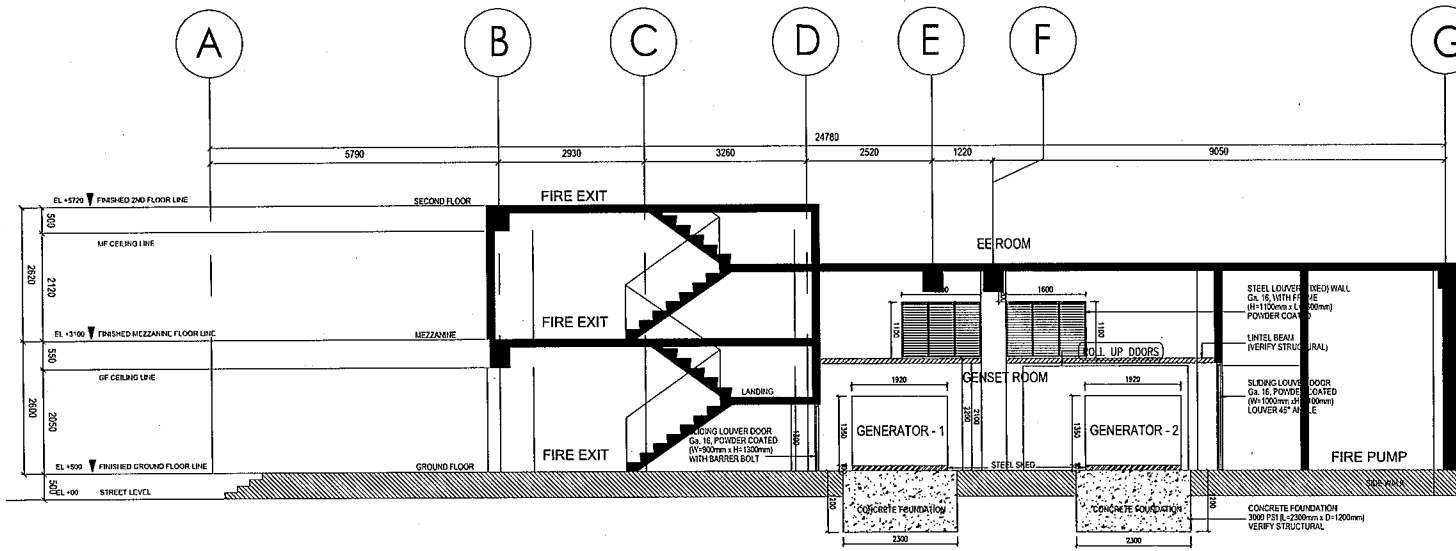


01 SECTION A  
E1/3 SCALE 1:50 MTS.

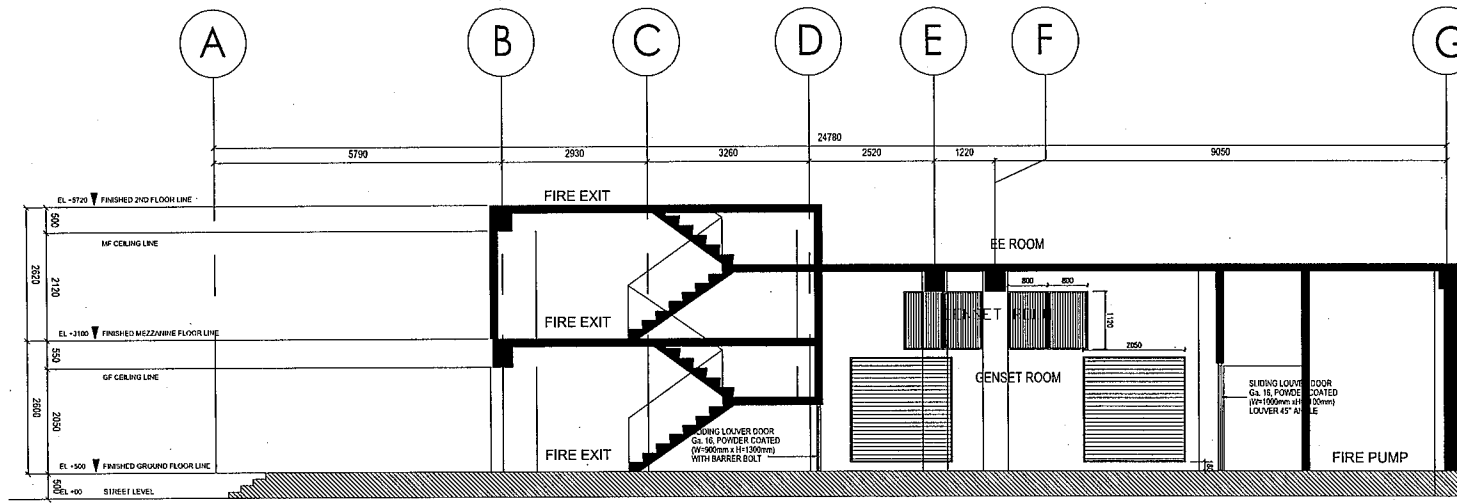

02 SECTION B  
E1/3 SCALE 1:50 MTS.

 <p><b>UNIVERSITY OF THE PHILIPPINES SYSTEM</b>          OVPD          OFFICE OF THE VICE PRESIDENT FOR DEVELOPMENT          ODPI          OFFICE OF DESIGN AND PLANNING INITIATIVES</p>	<p>REPUBLIC ACT 7546:          ARCHITECT ACT OF 1993          "The drawings, specifications and plans on this report, and documents of the contract of the profession."          I and my colleagues, as a profession, shall be responsible to the public, and shall not be held liable for any error or omission in the drawings, specifications and plans on this report, and documents of the contract of the profession."</p>	ARCHITECTS OF RECORD		CONSULTANT/ENGINEER		PROJECT TITLE		UNIVERSITY REPRESENTATIVE		OWNER		DRAWN BY: OJO		SHEET CONTENTS		SHEET NO.	
		DOLORES CECILIA F. TAYSON	JESUS APOLINARIO C. BULACONG	RODOLFO J. RENOLLA PROFESSIONAL ELECTRICAL ENGINEER		THREE - STOREY BUILDING RENOVATION Department of Budget and Management Arcache Building SAN RAFAEL CITY OF MARLA		ENRICO B. FARAFUNDA DIRECTOR ODP		BENJAMIN E. DIOKNO DEPUTY SECRETARY		ELVIRA A. ZAMORA VICE PRESIDENT OVPD		DATE: 12/18/2017 CHECKED BY: PJP DATE: 12/18/2017 REVISED BY: DEO DATE: 12/18/2017		SECTION A SECTION B	